


PLAN VIEW

PROVIDE ANTI-SLIP FLOOR FINISH UNDER SINK AND SURROUNDING

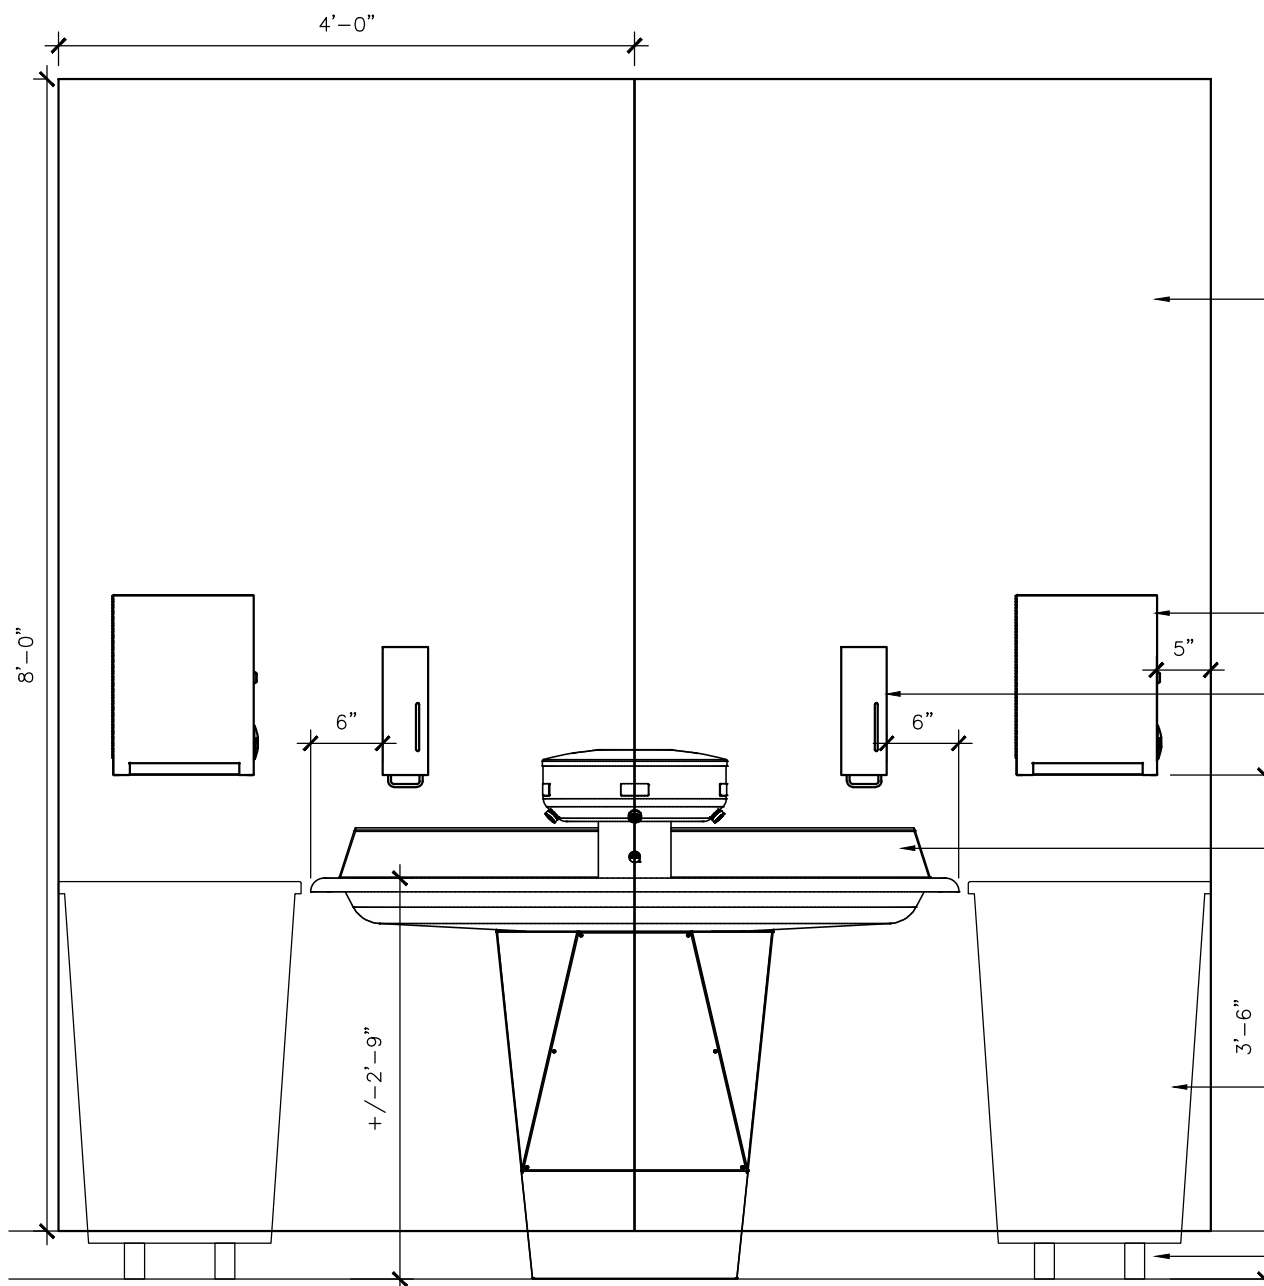

FRONT VIEW

SEE SRP SPECIFICATIONS FOR STANDARD TOILET ACCESSORIES

2QTY STAINLESS STEEL WALL PROTECTION (48"Wx96"H) INSTALL ABOVE BASE AND ADD TRIM WITH SEALANT FOR A WATER TIGHT SEAL AND SMOOTH EDGES

PAPER TOWEL DISPENSER, SEE SRP STANDARD TOILET ACCESSORIES

GARAGE SOAP DISPENSER

GARAGE HAND SINK, SEE PLUMBING FIXTURE SPECIFICATIONS FOR APPROVED SPECIFICATION (AS REFERENCE ONLY: BRADLEY SN2004-A-STD-IRP-NSD-BS-NONE-SH IS SHOWN)

OWNER PROVIDED FREE STANDING WASTE BIN

SCHEDULED WALL BASE



GARAGE HANDSINK ACCESSORIES LAYOUT

|                        |                                      |
|------------------------|--------------------------------------|
| REV. NO. 001           | DWG. NO.                             |
| REV. DATE : 12-16-2021 | AGD-10                               |
| DRAWN BY : MM          | SCALE : 3/4" (PDF) / 1"= 1'-0" (CAD) |